


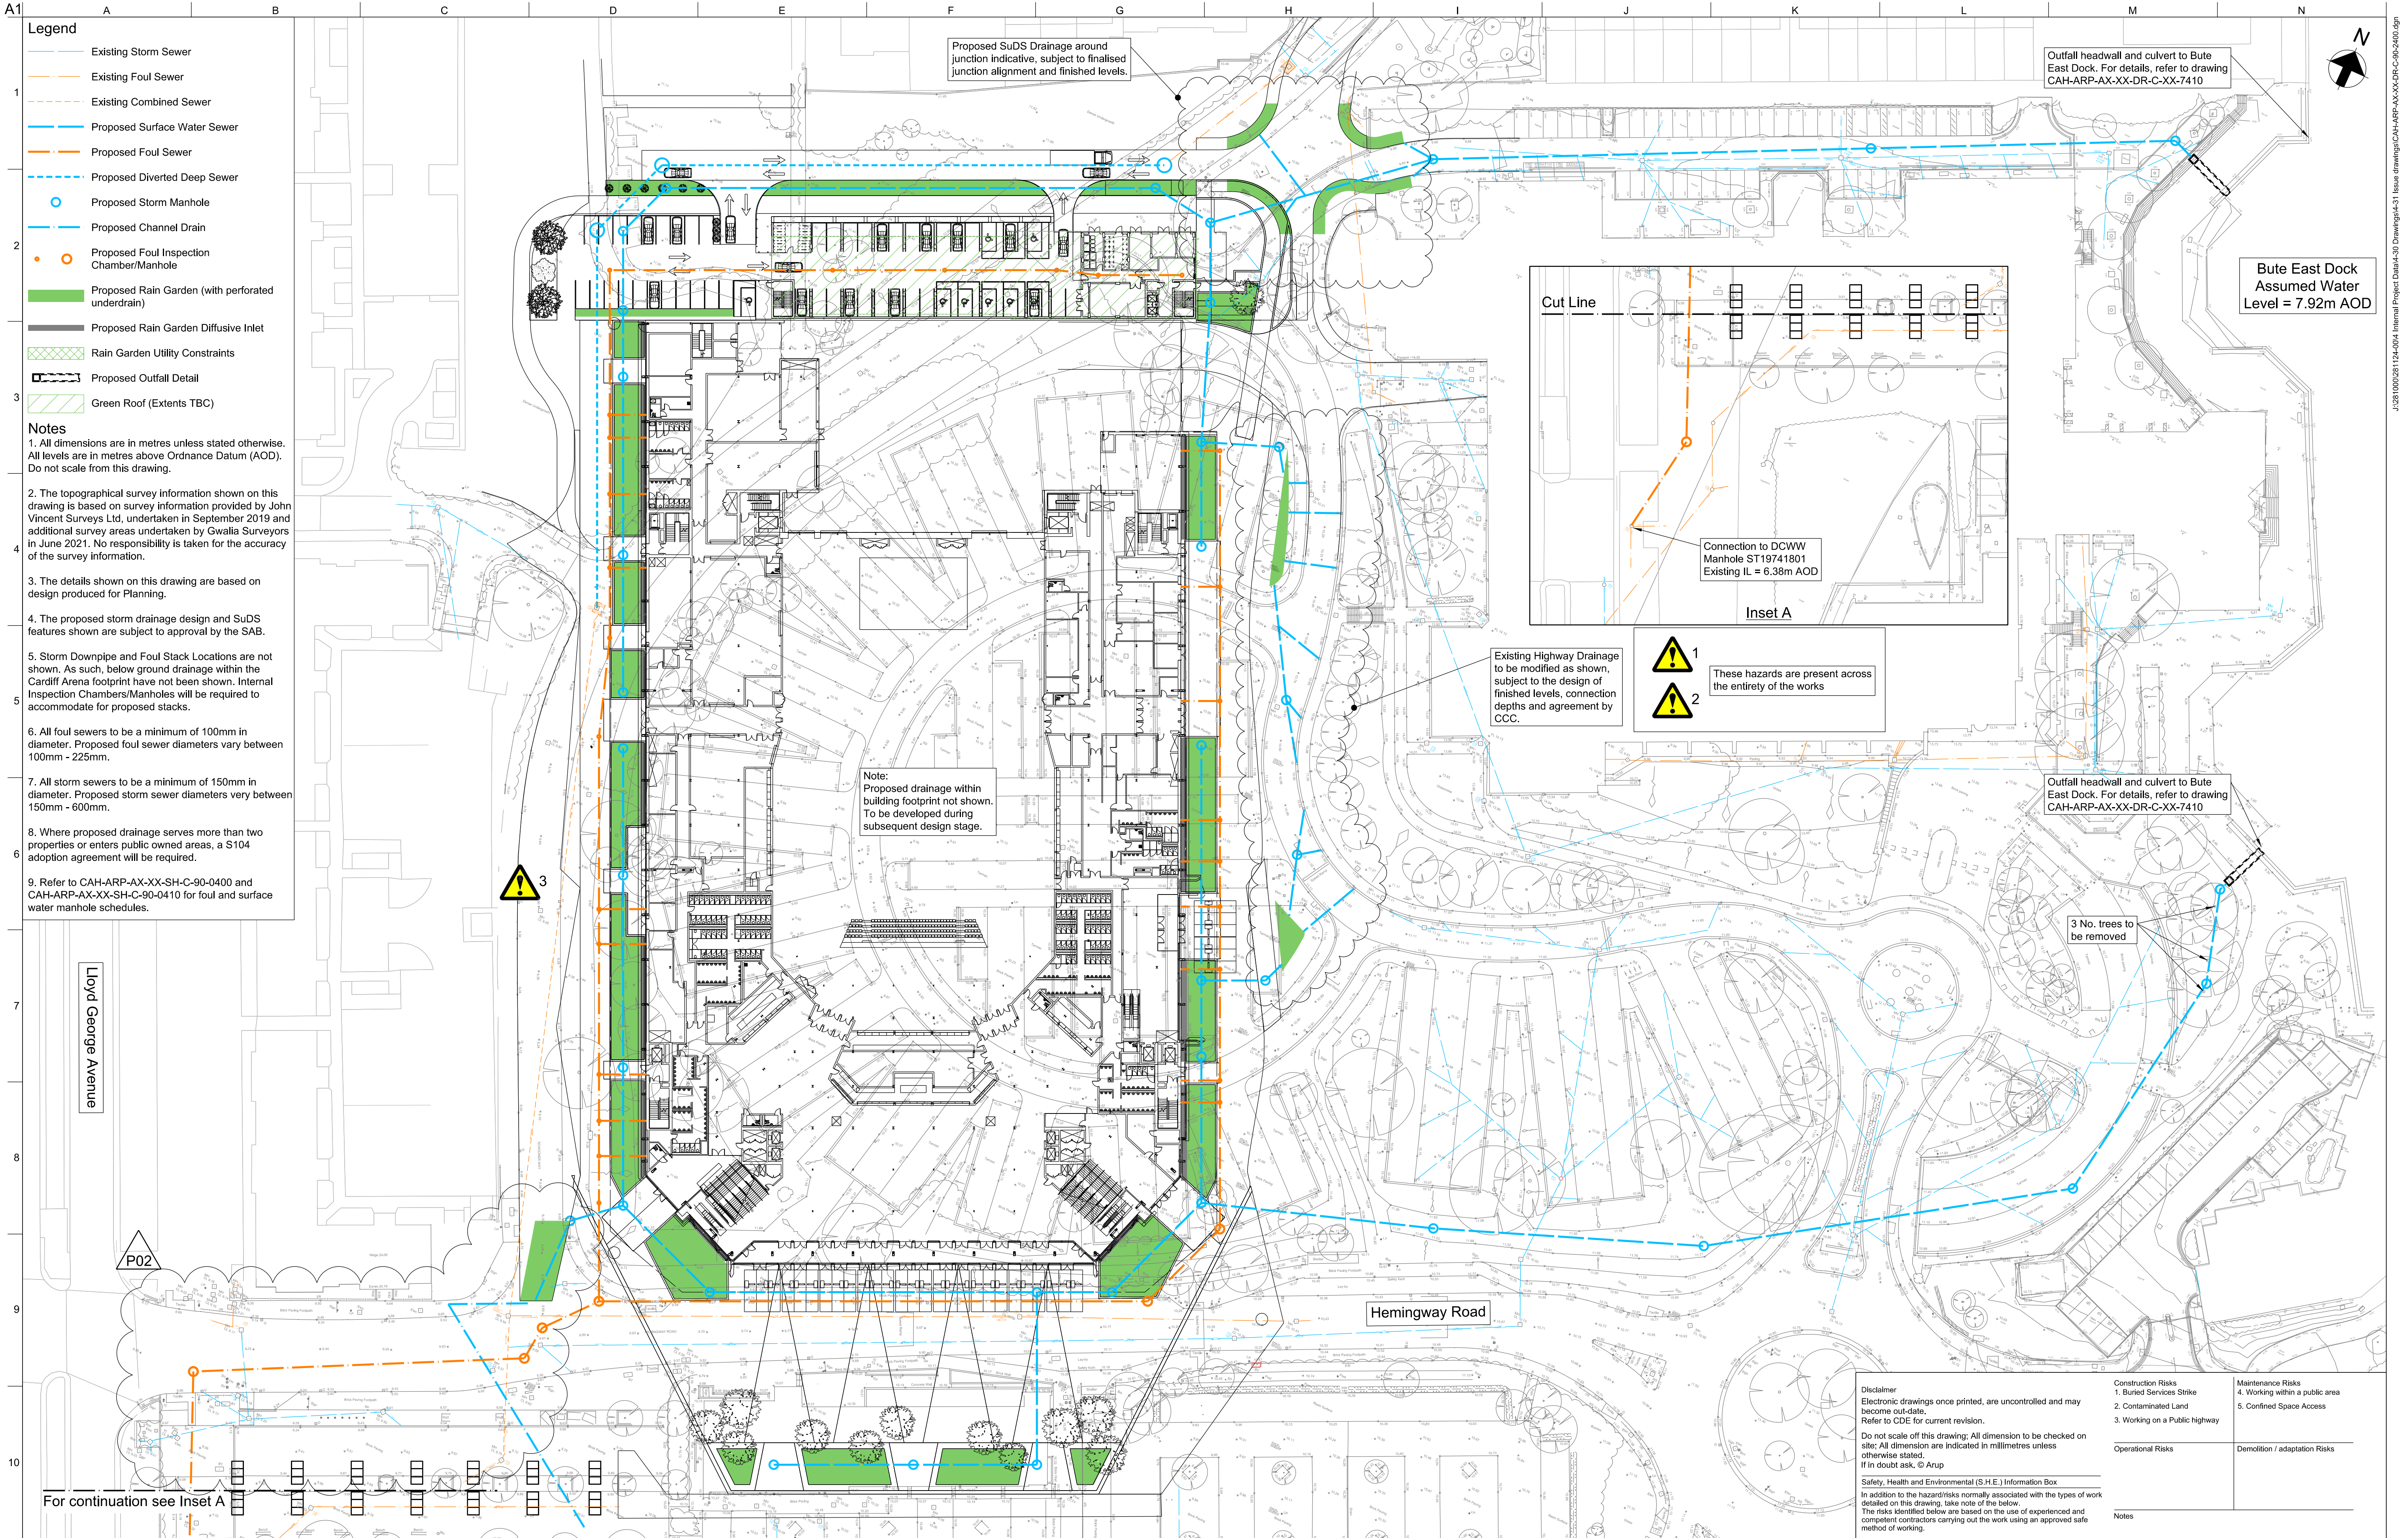

ARUP

4 Pierhead St, Capital Waterside
Cardiff, CF10 4QP
T +44(0)29 20473721 F +44(0)29 20472277
www.arup.com

P02	24/08/21	Rain garden areas updated
P01	30/07/21	Issued for Information
Issue	Date	Revision Description
Record of Revisions		

Client



Operators



Lead Designer



Project Title

Cardiff Arena & Hotel

Key Plan

Drawing Title

Proposed Drainage Layout

Scale at A1 1:500

Role

Civils

Drawn By

CB

Checked By

RV

Approved By

JS

Purpose of Issue

Information

Project No

281124

Rev

P02

ID

CAH-ARP-AX-XX-DR-C-90-2400